



FLOOR PLAN LAYOUT

- NOTES:
1. SEE DNG 5196-B-005 FOR SUGGESTIONS REGARDING BUILDING DESIGN.
 2. DIMENSIONS SHOWN IN BRACKETS ARE IN MILLIMETERS.
 3. F.F.L. = FINISHED FLOOR LEVEL.
 4. FD = FLOOR DRAIN TO OPEN SEWER.

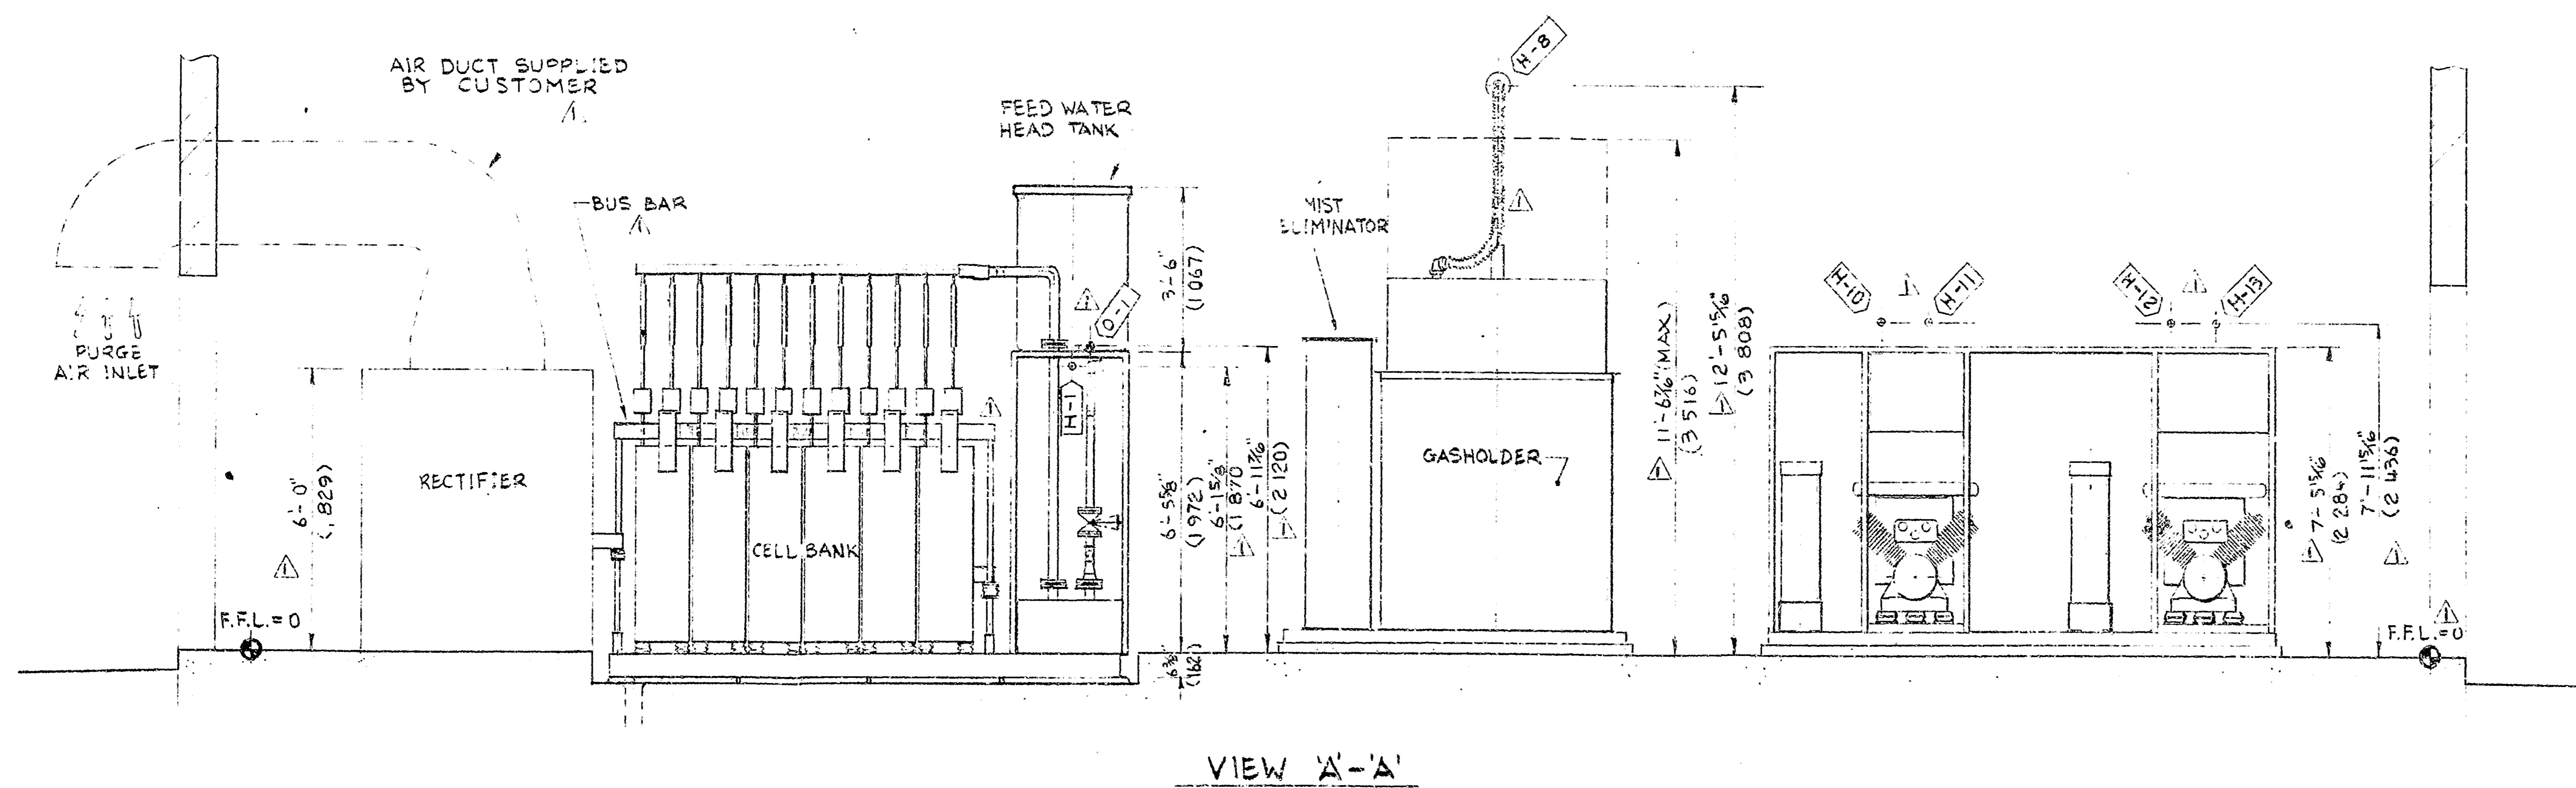

VIEW 'A-A'

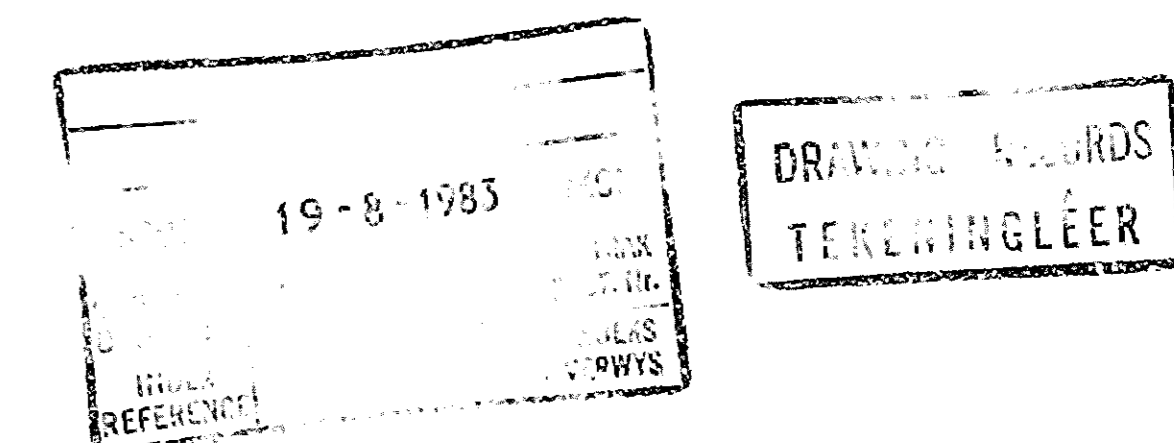

061/2066 Rv1

MAY 24/83 GENERAL REVISION		R/S	
REV No.	DATE	DESCRIPTION	APPL.
THIS DRAWING IS THE PROPERTY OF THE ELECTROLYSER CORPORATION LIMITED		THE ELECTROLYSER CORPORATION LTD. TORONTO CANADA	
THE INFORMATION AND KNOWLEDGE WHICH APPEAR ON IT MUST NOT BE USED OR DISCLOSED OR IN PART WITHOUT THE WRITTEN PERMISSION OF THE ELECTROLYSER CORPORATION LTD. ALL UNAUTHORIZED PRODUCTIONS MUST BEAR THIS NOTICE		1. EQUIPMENT LAYOUT	
DRAWN P.K. LEE	APPROVED R/S	SCALE 1:30	CUSTOMER TUTUKA ESCOM, S. AFRICA
CHECKED R/S	DATE JAN. 4/83	DRAWING No. 5196-D-004/C341	