


LEGEND:

- 70mm² BCEW BURIED AT 1000mm DEPTH
- Ø16mm VERTICALLY DRIVEN 1.2m EXTENSIBLE EARTH ROD
- CADWELD CONNECTION
- EARTH LUG CONNECTION

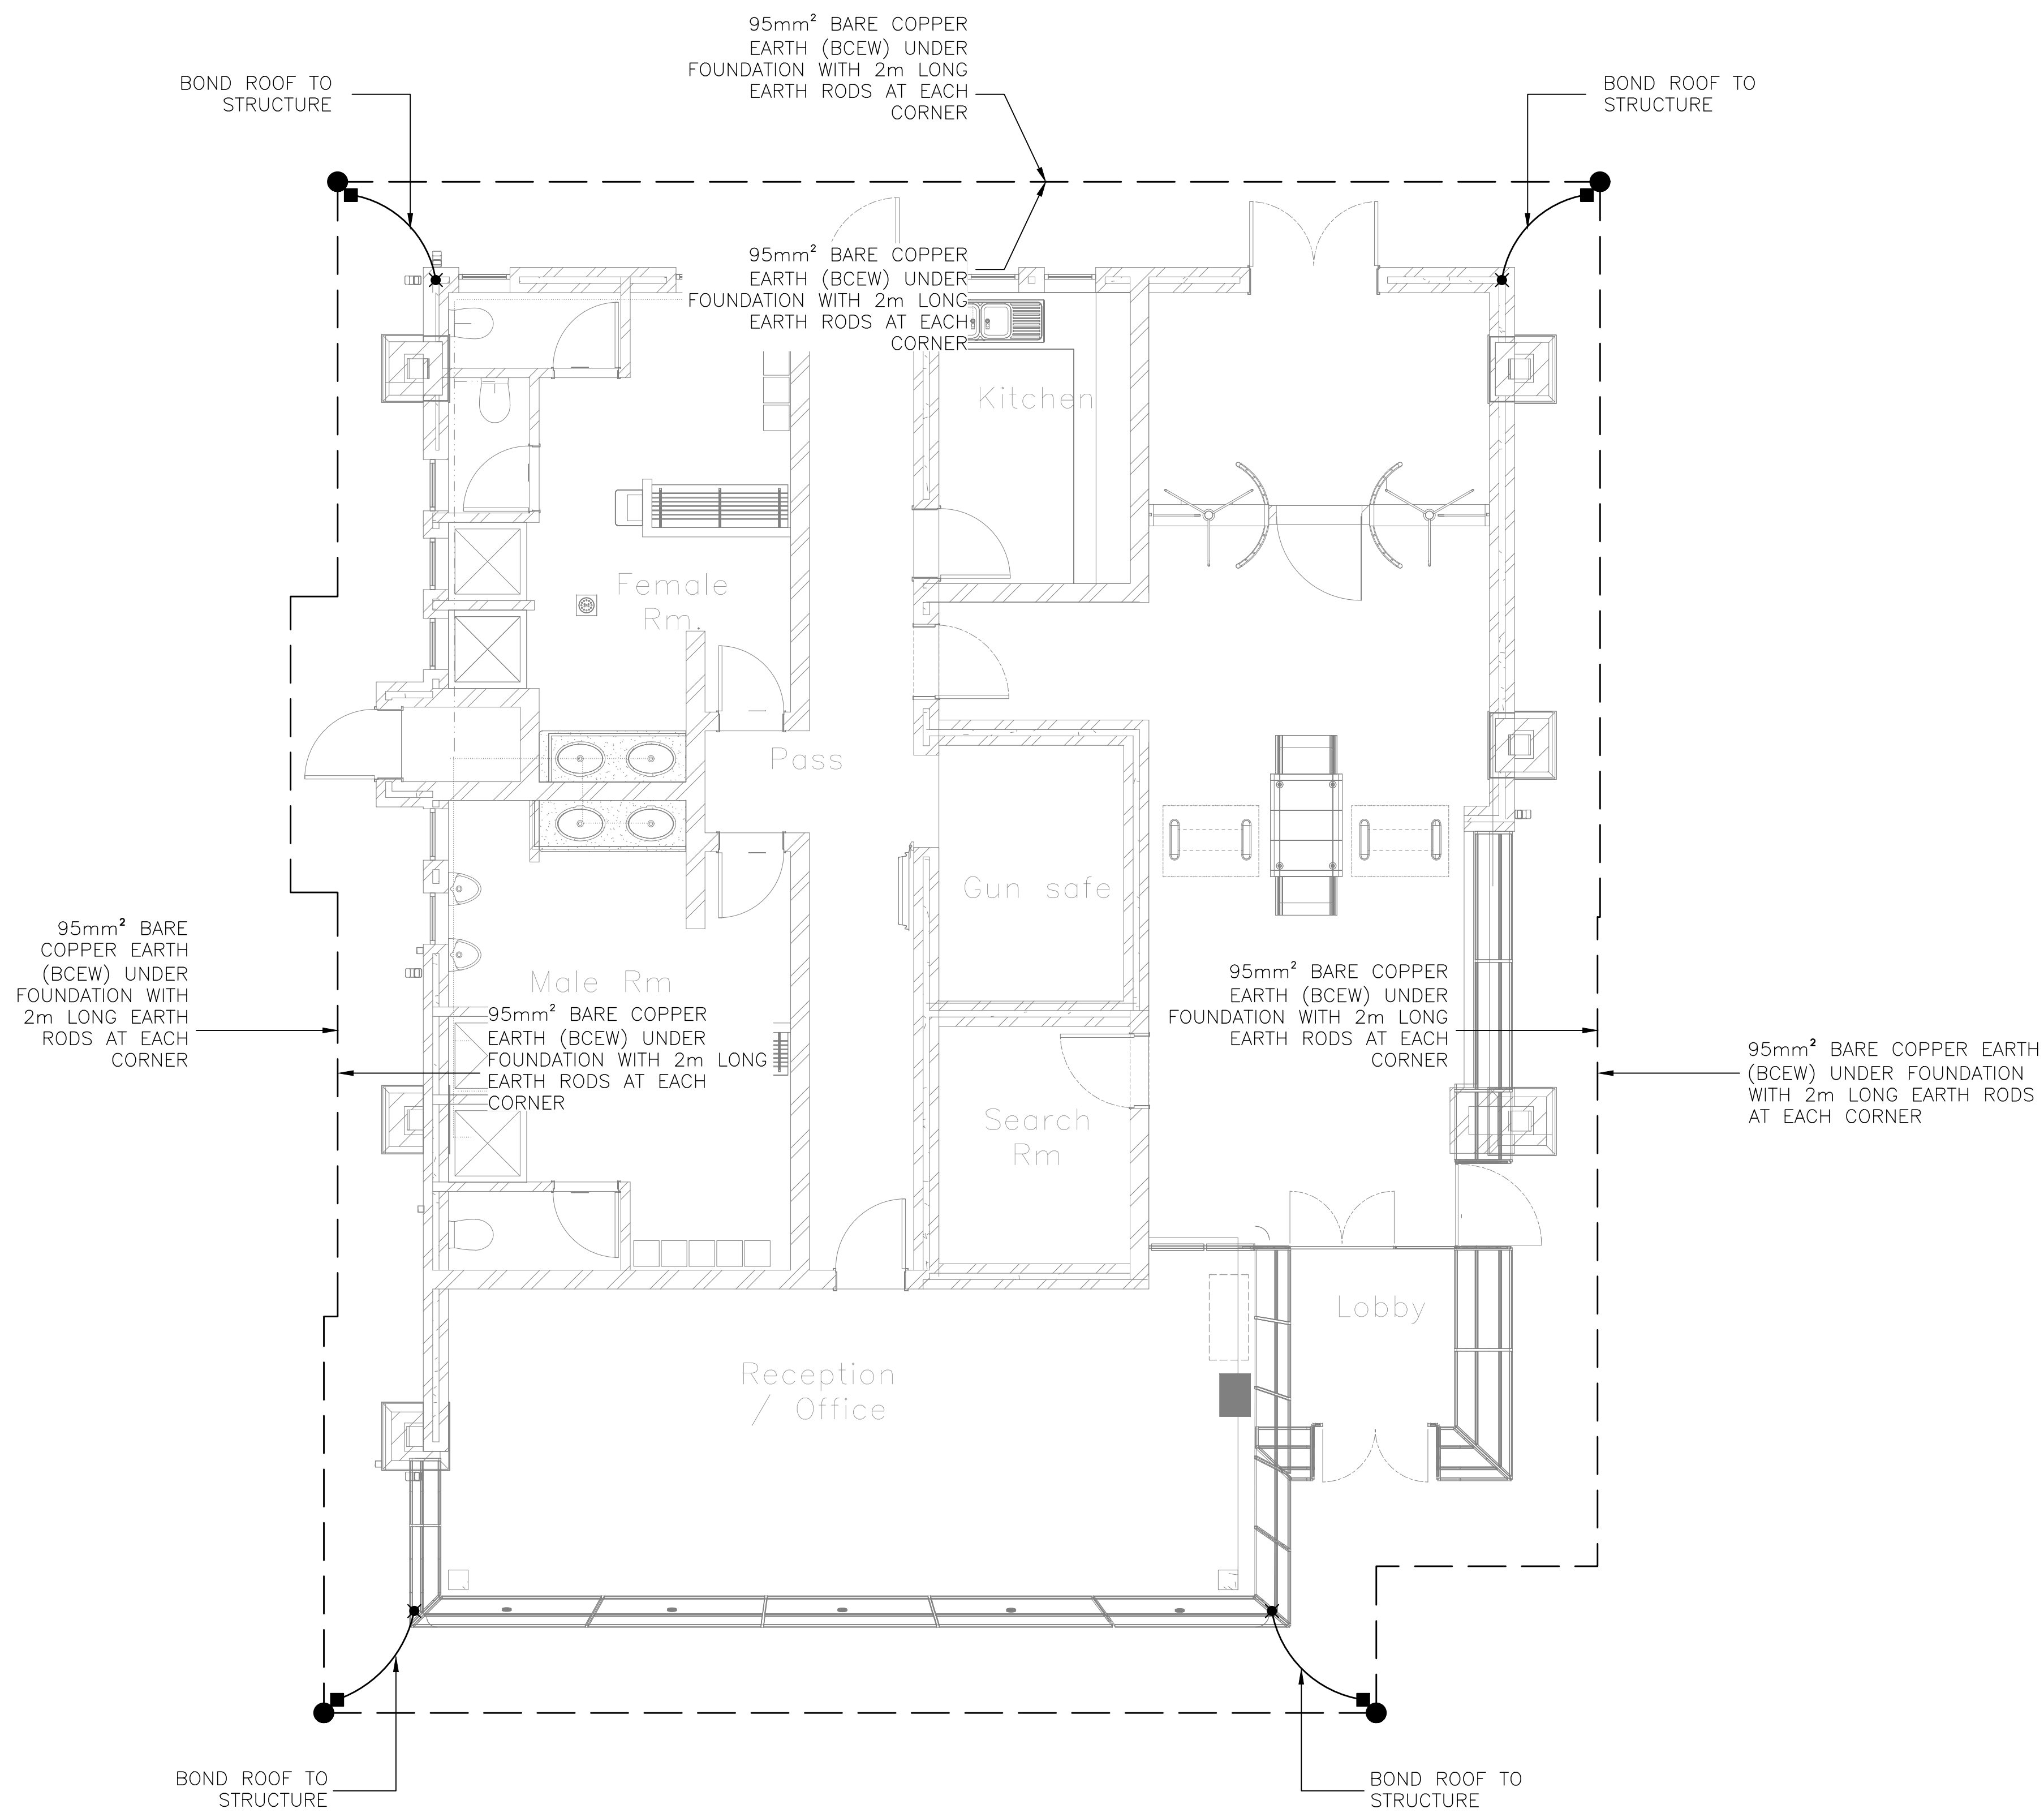

FLOOR PLAN
ILLUSTRATION OF EARTH CONDUCTORS
SCALE 1:50


 
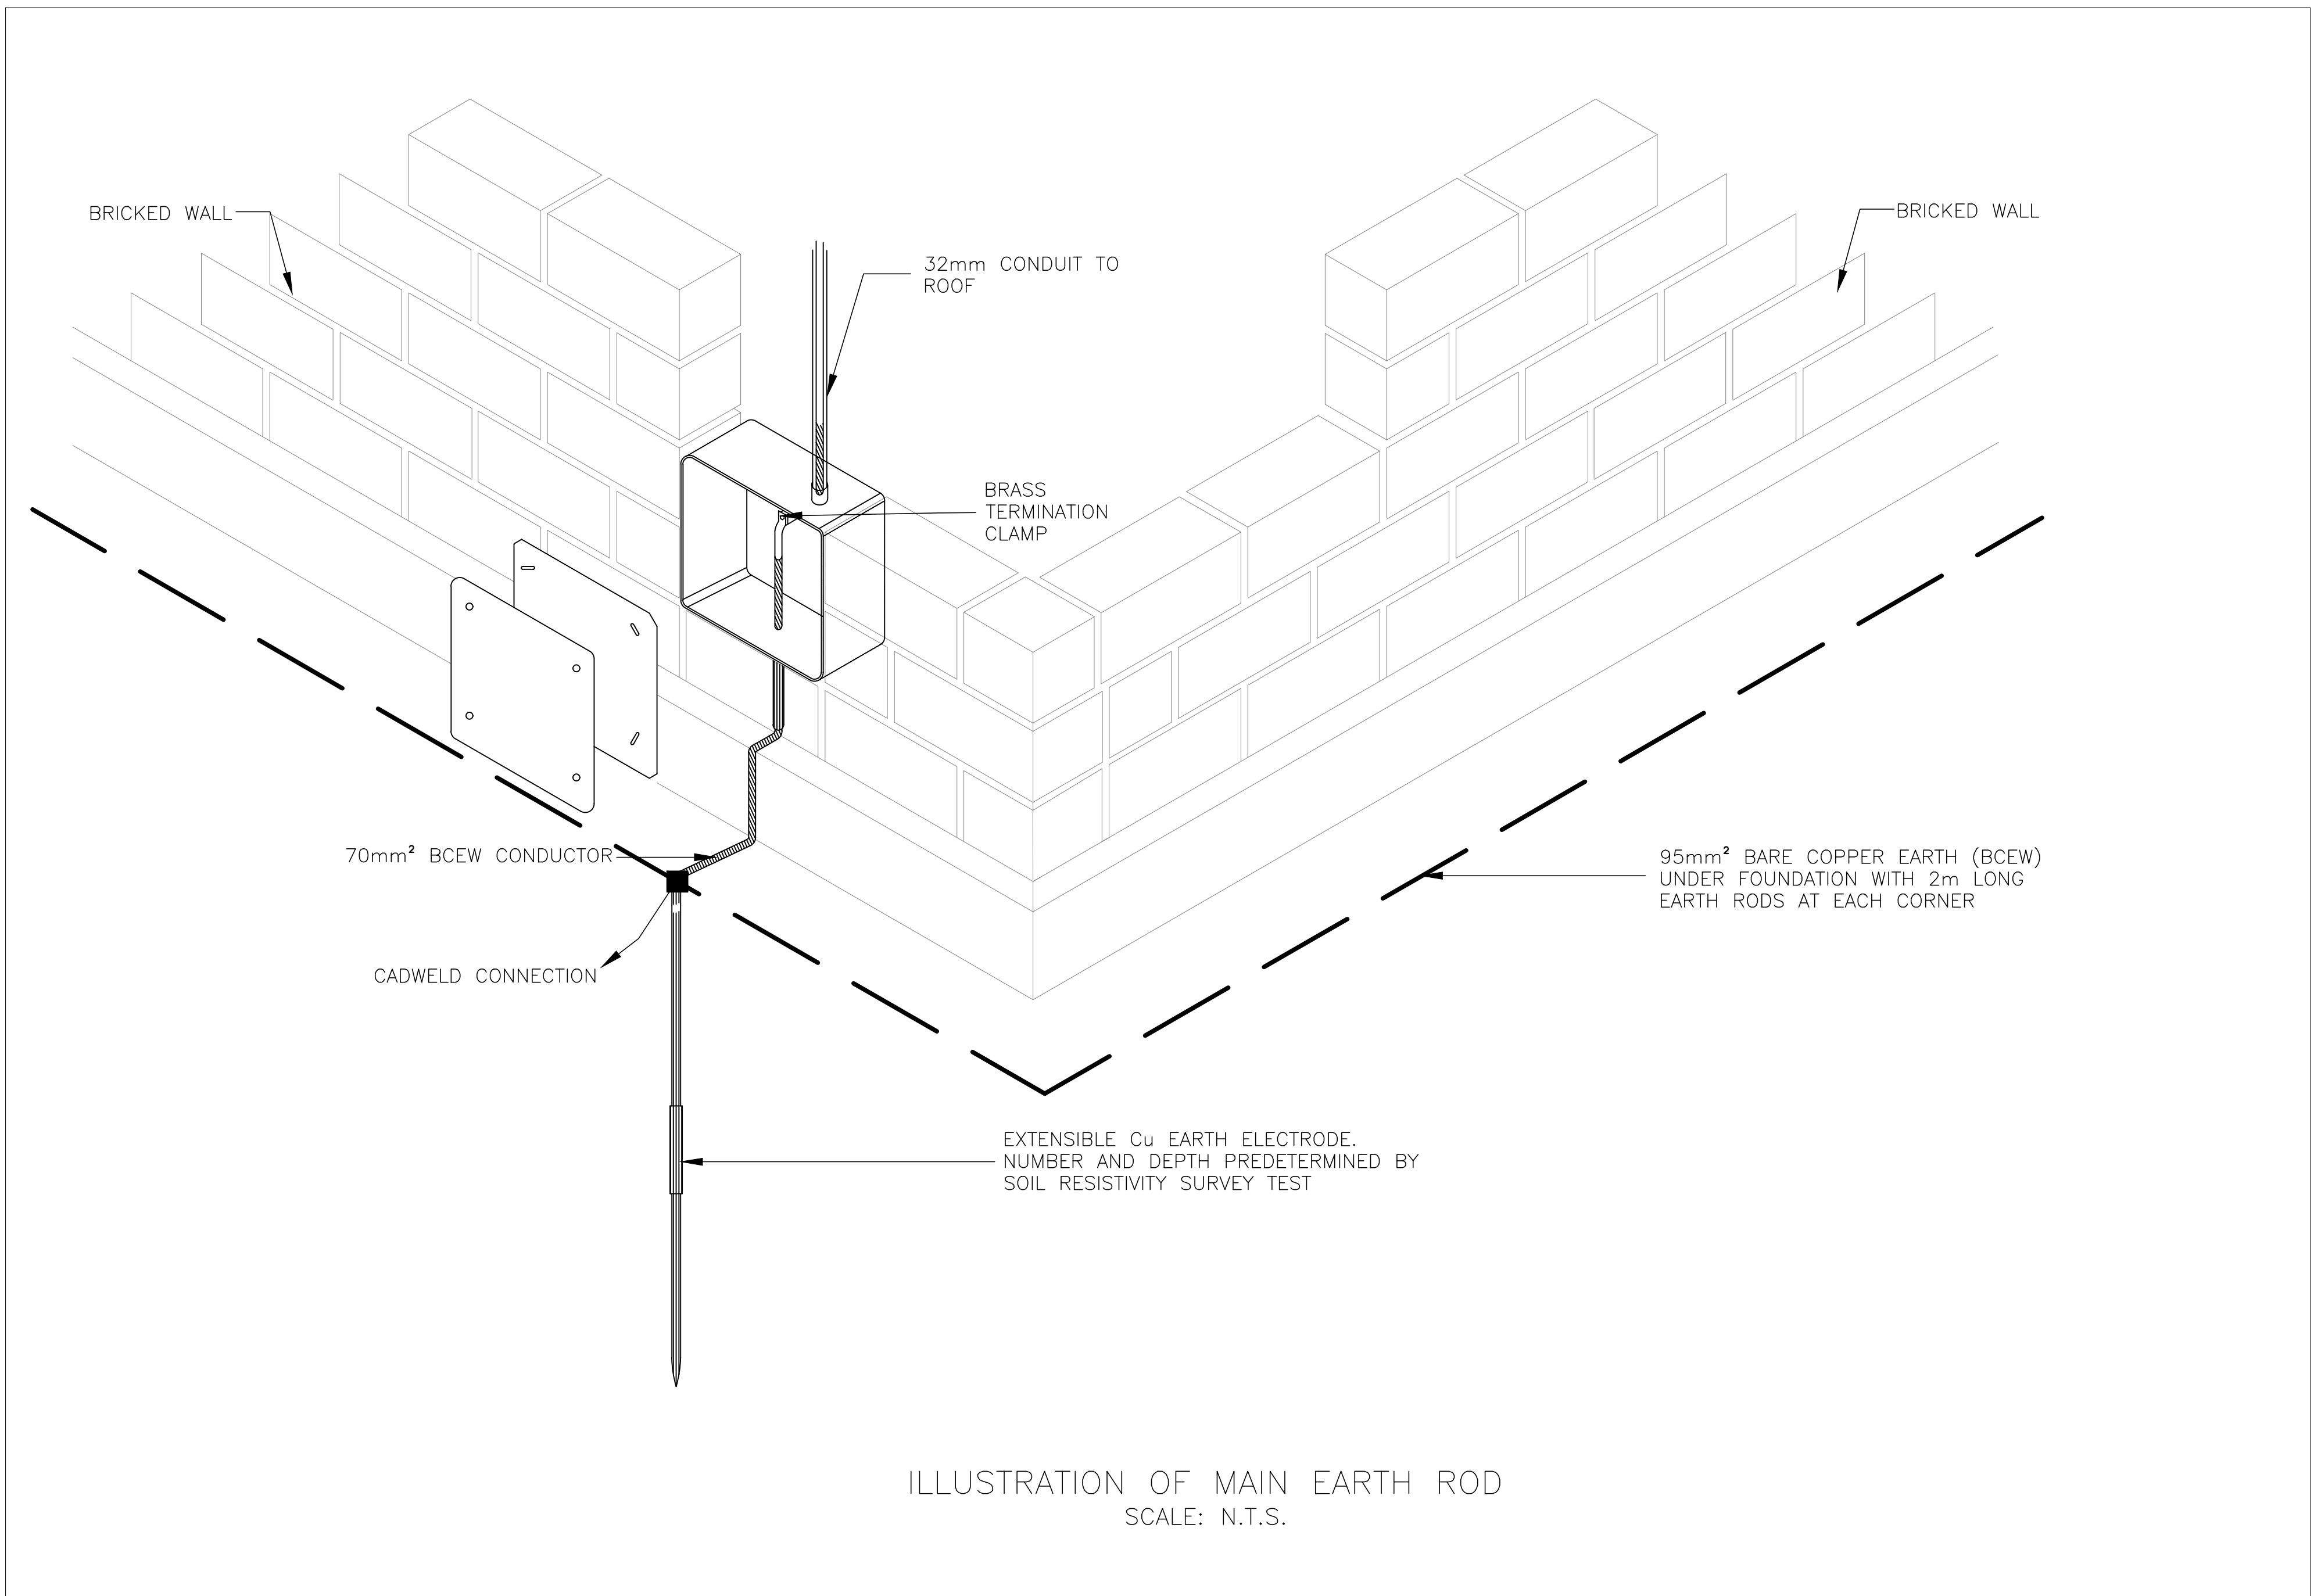


ILLUSTRATION OF MAIN EARTH ROD
SCALE: N.T.S.

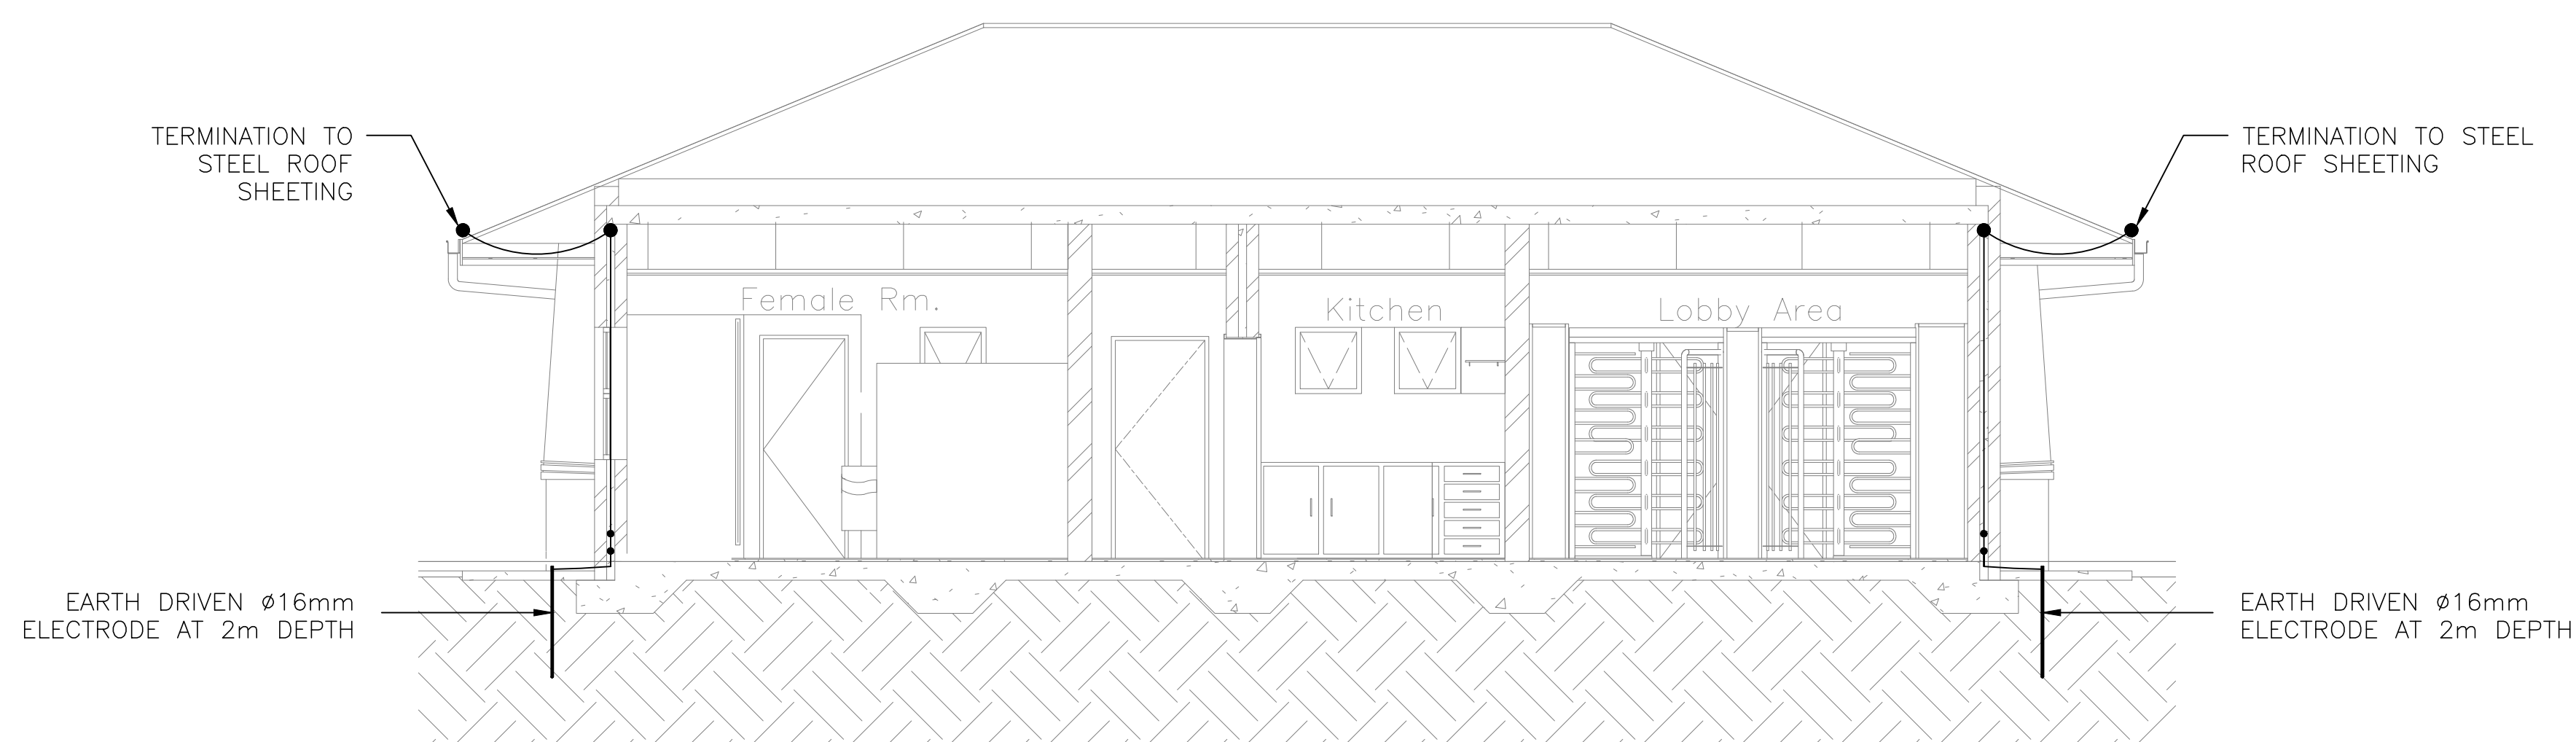

TYPICAL SECTION FOR ILLUSTRATION OF
EARTH CONDUCTORS
SCALE 1:50

BRAAMHOEK CONSULTANTS JOINT VENTURE

ARCUS GIBB **Royal HaskoningDHV** **Knight Piésold**

THE COPYRIGHT OF THIS DRAWING, INCLUDING THE DESIGN & DETAILS SHOWN HEREON, IS OWNED BY ESKOM HOLDINGS LTD. THIRD PARTIES SHALL NOT USE THIS DRAWING IN WHOLE OR IN PART WITHOUT THE WRITTEN PERMISSION OF ESKOM HOLDINGS LTD.

NO	REV	DATE	DESCRIPTION	BY	CHKD	APPD
1	08/12/16		DRAWING UPDATED AND ISSUED TO ESKOM FOR REVIEW	AG	KB	KG
2	24/07/16		FOR DRAWING UPDATED FOR REVIEW BY ESKOM	LH	KB	KG

FOR REFERENCE DRAWINGS REFER TO NOTE ON DRAWING

APPROVED BY: _____

DESIGNED BY: _____

CHKD BY: _____

DRAWN BY: _____

SCALE: AS SHOWN

ESKOM HOLDINGS LTD. REG. No. 2002/015527/06

NATIONAL KEY POINT FENCE AND ACCESS ROAD
NEW SECURITY BUILDING
EARTHING LAYOUT

Eskom 0.83/79 406 SHEET 2 1b

0 500 1000 1500 2000mm
1:25 ON ORIGINAL