



BRICKWORK OF SEPARATING WALL TO EXTEND TO UNDERSIDE OF ROOF

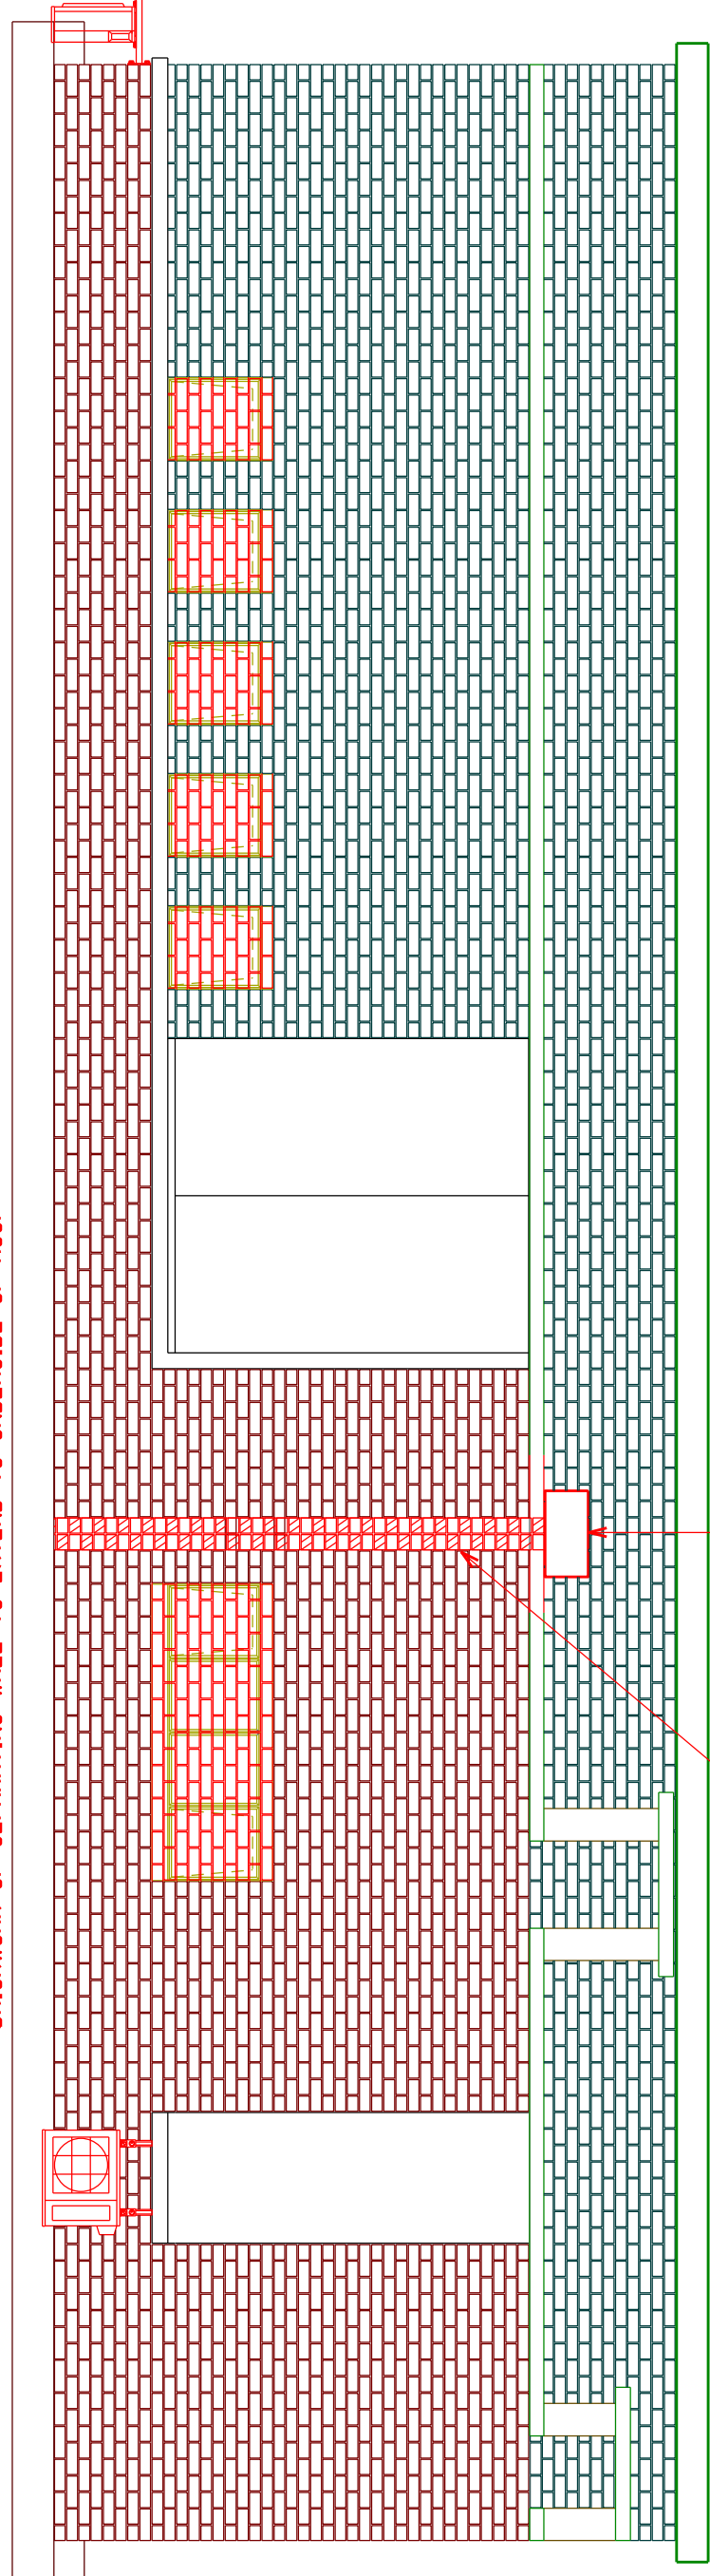


NEW 220mm NFX WALL
PLASTERED BOTH SIDES

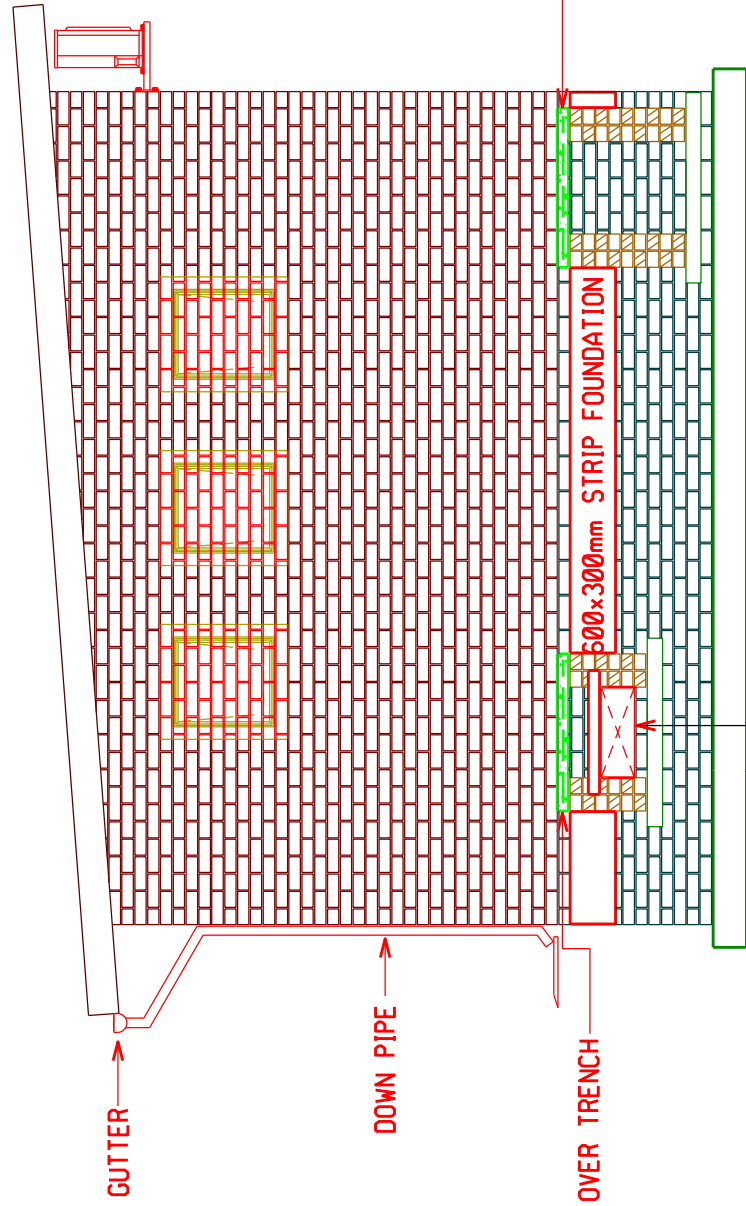


EAST ELEVATION

1150mm U SHAPED PVC GUTTERS
ON BRACKETS AT 900mm
AND 1150mm RAINWATER DOWNPIPE

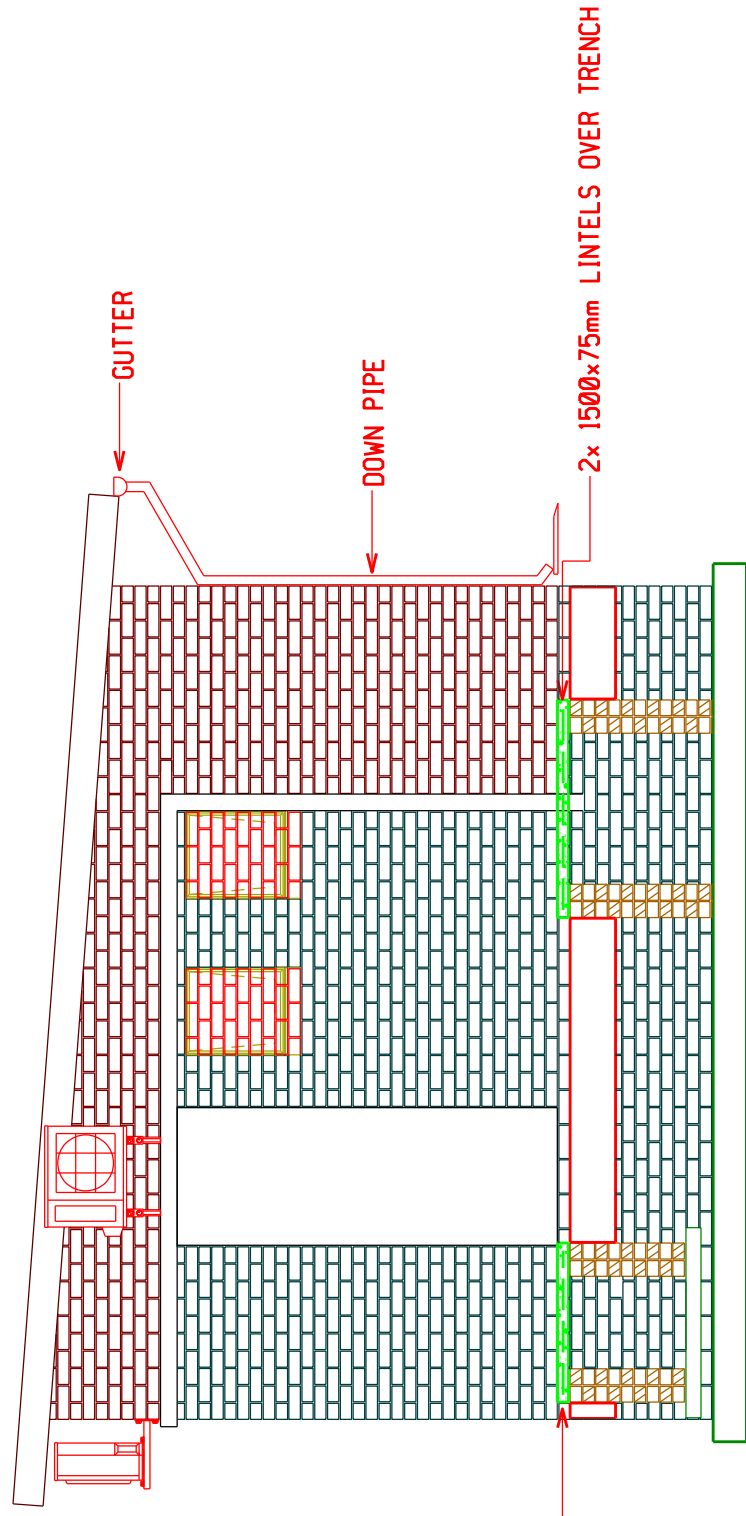

WEST ELEVATION

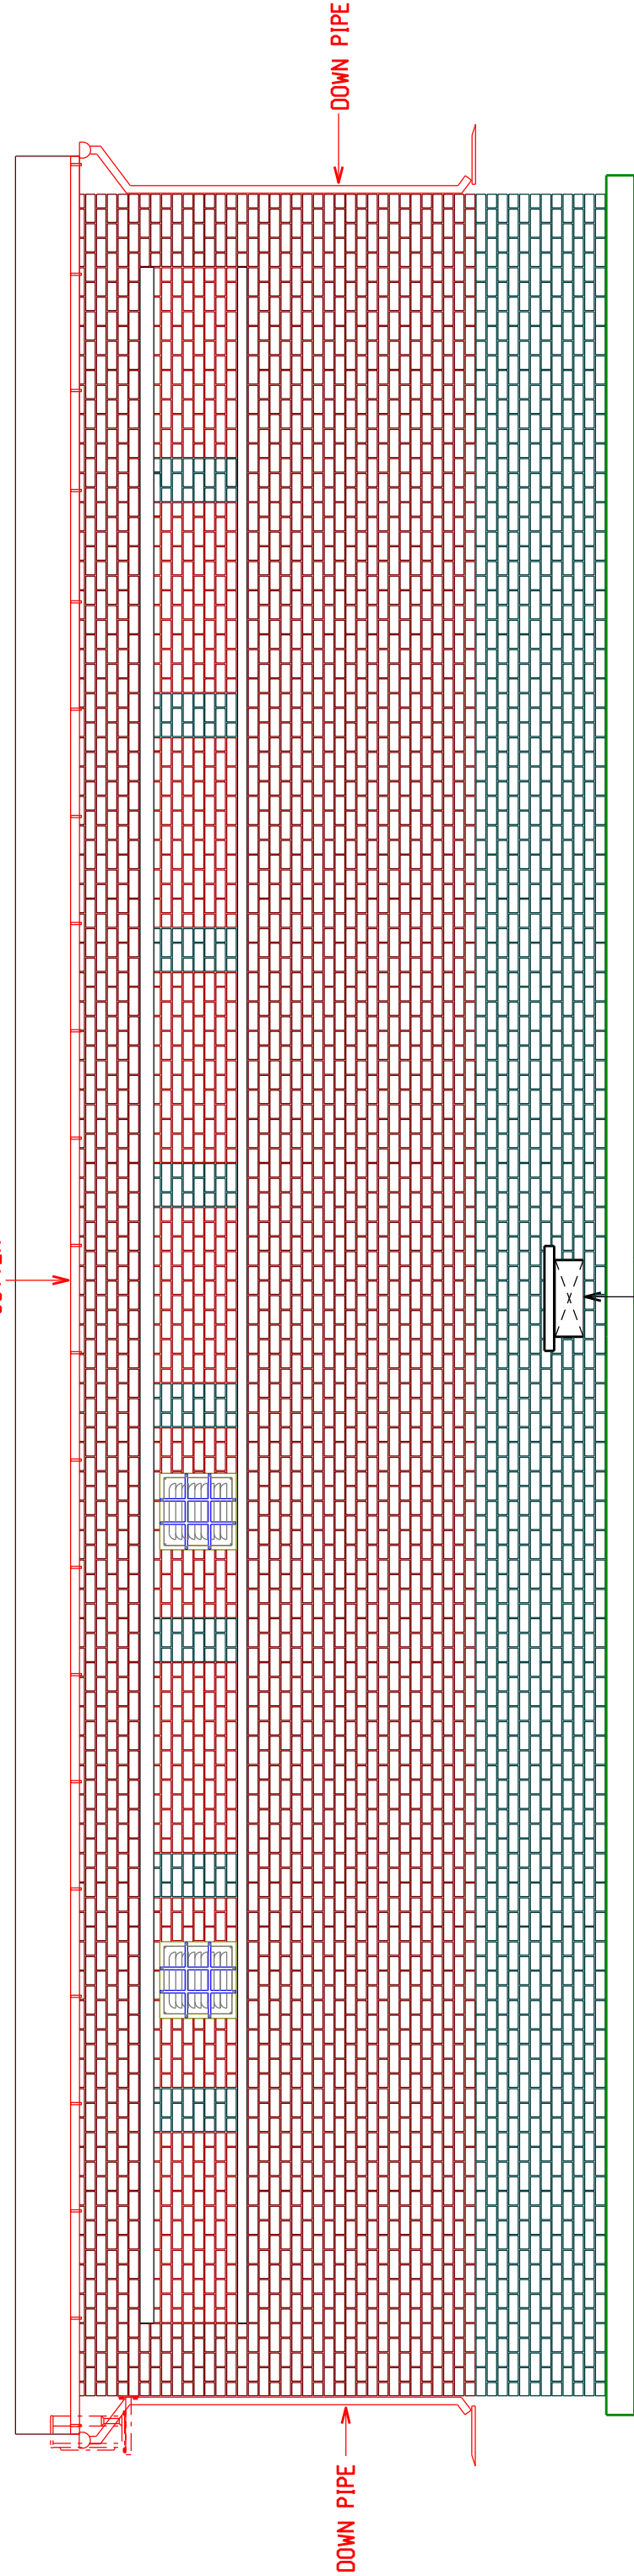

SOUTH ELEVATION

UMKOMAAS SUBSTATION				ER00779			
CONTROL / SWITCH ROOM				SET	SHEET	REVISION	
ELEVATIONS				19	02	00	
CHECKED G Pillay 29/01/2021		AUTHORIZED PD Chetty 01/02/2021		Eskom Distribution			
DRAWN T D O'Brien 12/12/2018		SCALE 1:50					
REV		DRAWN		CHKD		APPROVED	
00		TD08		CP		POC 01/02/21	
						29/01/21	
						DATE	
						FIRST ISSUE	
						REVISION DESCRIPTION	